


Ventura Housing Authority SANTA CLARA APARTMENTS "GREEN" RENOVATION

1216 E. SANTA CLARA STREET
VENTURA, CALIFORNIA 93001

PLAN CHECK CORRECTIONS
SEPTEMBER 30, 2010

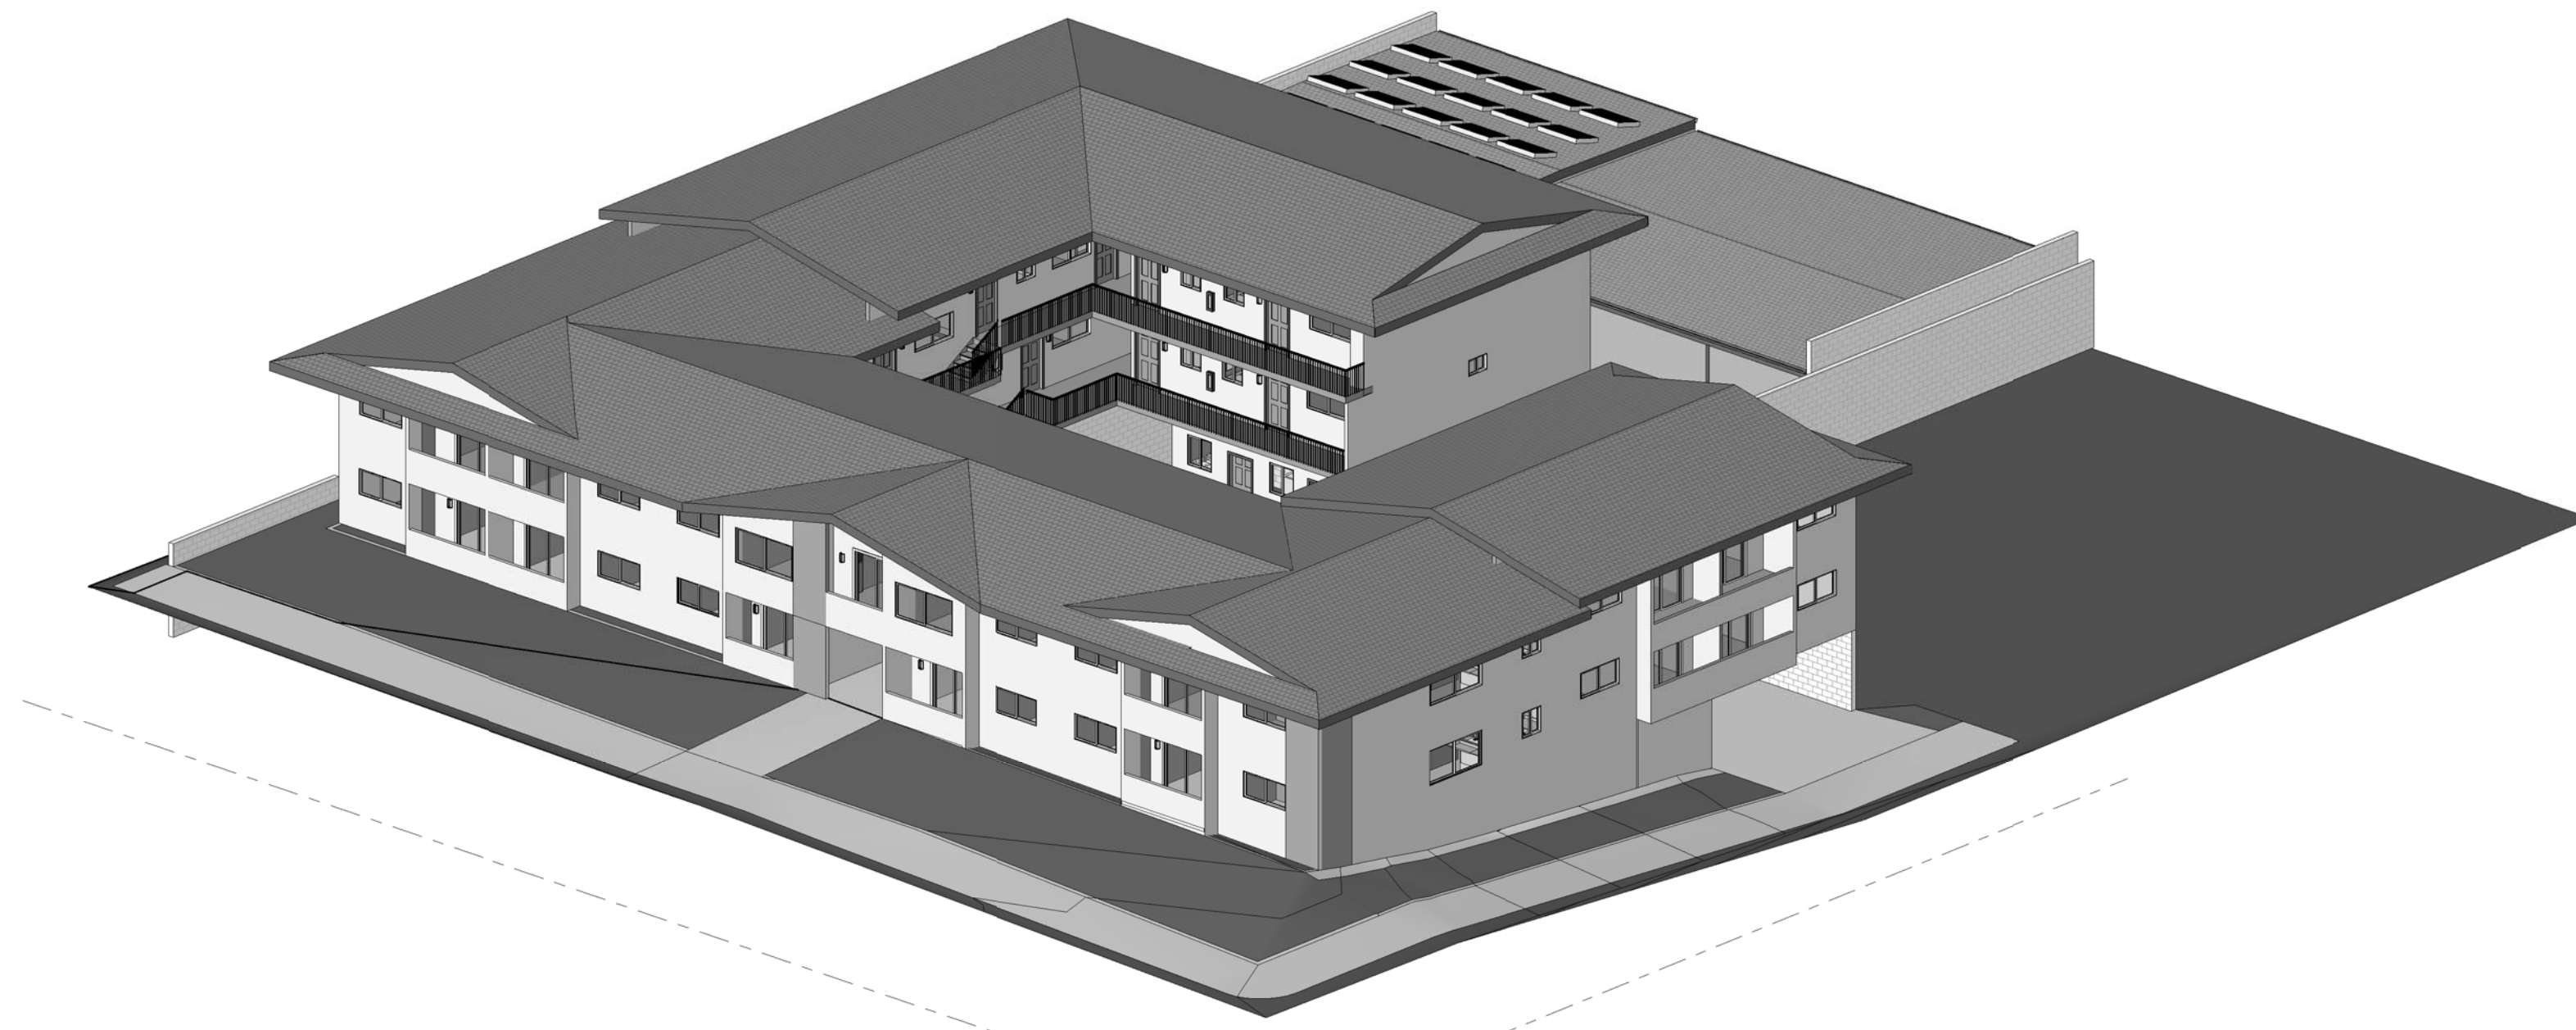

2 NORTH WEST VIEW



1 SOUTH WEST VIEW

DRAWING LIST		DRAWING LIST	
SHT. NO.	DRAWING TITLE	SHT. NO.	DRAWING TITLE
GENERAL		PLUMBING	
G0.00	TITLE SHEET	P1.01	PLUMBING SCHEDULES AND NOTES
G0.01	GENERAL NOTES	P2.01	SITE/PARKING LEVEL PLAN
G0.02	CODE ANALYSIS SITE PLAN	P2.02	FIRST FLOOR PLAN
LANDSCAPE		P2.03	SECOND FLOOR PLAN
L1.0	IRRIGATION PLAN	P3.01	PLUMBING DIAGRAMS
L2.0	PLANTING PLAN	P3.02	PLUMBING DIAGRAMS
L3.0	DETAILS	MECHANICAL	
ARCHITECTURAL		M0.01	GENERAL NOTES, SYMBOLS & ABBREVIATIONS
A1.01	SITE/PARKING LEVEL PLAN	M0.02	MECHANICAL SCHEDULES
A1.02	FIRST FLOOR PLAN	M1.02D	FIRST FLOOR HVAC DEMOLITION PLAN
A1.03	SECOND FLOOR PLAN	M1.03	SECOND FLOOR HVAC DEMOLITION PLAN
A1.04	PARKING REFLECTED CEILING PLAN	M2.01	ENLARGED PARKING LEVEL PLAN
A1.05	FIRST FLOOR REFLECTED CEILING PLAN	M2.02	FIRST FLOOR PLAN
A1.06	SECOND FLOOR REFLECTED CEILING PLAN	M2.03	SECOND FLOOR PLAN
A2.01	EXTERIOR ELEVATIONS	M3.01	MECHANICAL DIAGRAMS
A2.02	EXTERIOR COURTYARD ELEVATIONS	M4.01	TITLE 24 PERFORMANCE CERTIFICATES
A3.01	BUILDING SECTIONS	M4.02	TITLE 24 PERFORMANCE CERTIFICATES
A4.01	ENLARGED PLAN AND TYPICAL INTERIOR ELEVATIONS	M4.03	TITLE 24 PERFORMANCE CERTIFICATES
A5.01	DOOR & WINDOW DETAILS	M4.04	TITLE 24 PERFORMANCE CERTIFICATES
A5.02	EXTERIOR AND MISCELLANEOUS DETAILS	M4.05	TITLE 24 PERFORMANCE CERTIFICATES
A6.01	DOOR AND WINDOW SCHEDULES AND FINISHES LIST	M4.06	TITLE 24 PERFORMANCE CERTIFICATES
STRUCTURAL		ELECTRICAL	
S0.00	GENERAL NOTES	E0.01	GENERAL NOTES & SYMBOLS
S1.01	FND. & ROOF FRAMING PLAN	E0.02	SINGLE LINES & PNL SCHEDS
S2.01	FOUNDATION DETAILS	E1.01	PARKING LEVEL DEMO PLAN
S3.01	FRAMING DETAILS	E1.02	FIRST FLOOR DEMO PLAN
		E1.03	SECOND FLOOR DEMO PLAN
		E2.01	PARKING LEVEL PLAN
		E2.02	FIRST FLOOR PLAN
		E2.03	SECOND FLOOR PLAN
		Grand total:	51

SCOPE OF WORK

IN THE EXISTING 2 STORY 28 UNIT APARTMENT BUILDING THE FOLLOWING IS TO BE REMOVED, REPLACED AND/OR INSTALLED:

EXTERIOR DOORS, WINDOWS, EXTERIOR WALL INSULATION, ROOF INSULATION, INTERIOR AND EXTERIOR LIGHTING FIXTURES, PLUMBING FIXTURES, WALL FURNACES, STOVE/OVENS, STOVE HOODS, BATHROOM LIGHT SWITCHES, BATHROOM EXHAUST FANS, ELECTRICAL WORK, INDIVIDUAL METERS FOR UNITS, PHOTOVOLTAIC PANELS, LANDSCAPING AND IRRIGATION SYSTEM, NEW HYDRONIC RADIATORS, HYDRONIC LOOP, BOILERS AND CIRCULATION PUMP.

EXISTING WALLS, ROOFS, CEILINGS, CASEWORK, AND FINISHES ARE NOT TO BE ALTERED EXCEPT TO PERFORM THE REQUIRED WORK.

THE EXISTING CARPORT SHALL BE ALTERED PER STRUCTURAL DRAWINGS TO SUPPORT NEW PHOTOVOLTAIC PANELS.

THIS IS A GENERAL SUMMARY OF WORK AND DOES NOT LIMIT OR CHANGE THE WORK DESCRIBED IN THE DRAWINGS AND SPECIFICATIONS.


DESIGN TEAM

ARCHITECT
AMADOR WHITTLE ARCHITECTS
17 EAST HIGH STREET, MOORPARK CA 93021
(805) 530-3938

MECHANICAL, ELECTRICAL, PLUMBING
BUDLONG & ASSOCIATES, INC.
5151 VERDUGO WAY SUITE 201
CAMARILLO, CA 93012
(805) 987-4001

LANDSCAPE ARCHITECTURE
LANDMARK DESIGN
275 E. HILLCREST DRIVE #170
THOUSAND OAKS, CA 91360
(805) 494-8155

STRUCTURAL
LI & ASSOCIATES, INC.
77 ROLLING OAKS DRIVE, SUITE 203
THOUSAND OAKS, CA 91361
(805) 495-3432

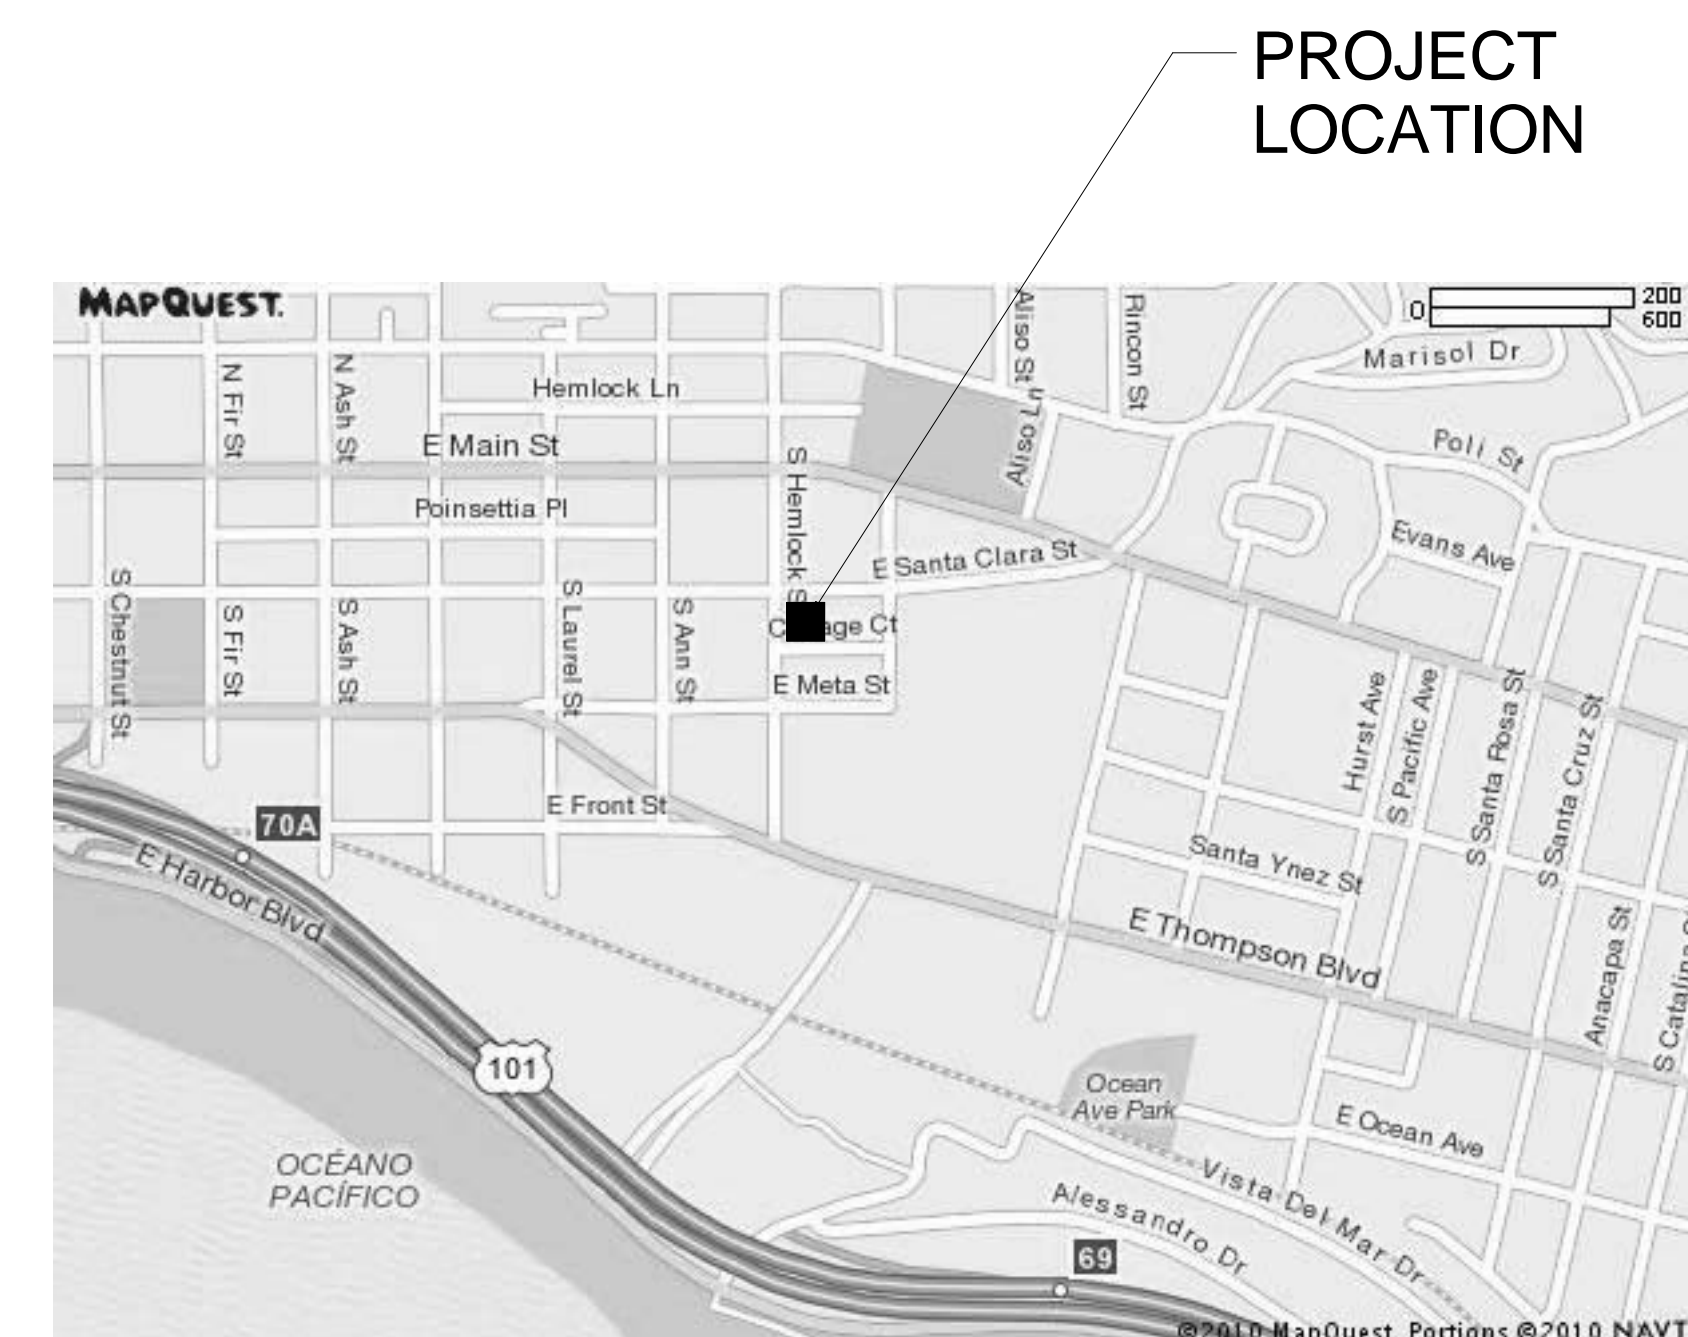

PROJECT
LOCATION

**AMADOR WHITTLE
ARCHITECTS, INC.**



17 EAST HIGH STREET
MOORPARK, CALIFORNIA 93021
TEL (805) 530-3938 FAX (805) 530-3942

**VENTURA HOUSING AUTHORITY
SANTA CLARA APTS. "GREEN" RENOVATION**

1216 E. SANTA CLARA ST., VENTURA, CA 93001

NOTE: THIS SHEET IS ONE OF A SET OF DOCUMENTS WHICH INCLUDES, BUT IS NOT LIMITED TO, DRAWINGS AND SPECIFICATIONS ADDRESSING ALL TRADES. GENERAL CONTRACTOR IS RESPONSIBLE FOR FURNISHING ALL BIDDERS WITH A FULL SET OF CONSTRUCTION DOCUMENTS. ALL BIDDERS SHALL REVIEW THE ENTIRE SET OF DOCUMENTS. IF THERE IS A CONFLICT BETWEEN DISCIPLINES, THE MOST EXPENSIVE OPTION SHALL BE BID.

REVISIONS	1	09/30/10	BULLETIN #1 PLAN CHECK CORRECTIONS	DATE:	09/30/10
				DRAWN:	PAN
				CHECK:	-
				JOB NO:	10-VHA-028

TITLE SHEET

G0.00

IF THIS SHEET IS NOT 42" X 34", IT IS NOT FULL SIZE. SCALE DRAWINGS ACCORDINGLY.